

PROPOSED VERIZON WIRELESS OSHA FALL PROTECTION (SAFETY RAIL COMPANY P/N: (9) 420168, (14) 100155, (3) 400104, (1) 400107, (2) 400109)


NOTE: FINAL FIBER/TELCO ROUTING TO BE DETERMINED BY PROVIDER.

1 ROOF PLAN
LE-2 SCALE: 1" = 10'



Tectonic
PRACTICAL SOLUTIONS. EXCEPTIONAL SERVICE.
Tectonic Engineering Consultants, Geologists & Land Surveyors, D.P.C.
Project Contact Info
36 British American Blvd. Phone: (518) 783-1630
Suite 101 (800) 829-6531
Latham, NY 12110 www.tectonicengineering.com

SCHNEIDER AVE – LEASE EXHIBIT
PROJECT # 20202142274 – LOCATION CODE # 636584
303 MAIN ST – VILLAGE OF HIGHLAND FALLS – ORANGE COUNTY, NY 10928
VERIZON WIRELESS OF THE EAST, LP
(LESSEE)
1275 JOHN STREET, SUITE 100, WEST HENRIETTA, NY 14586

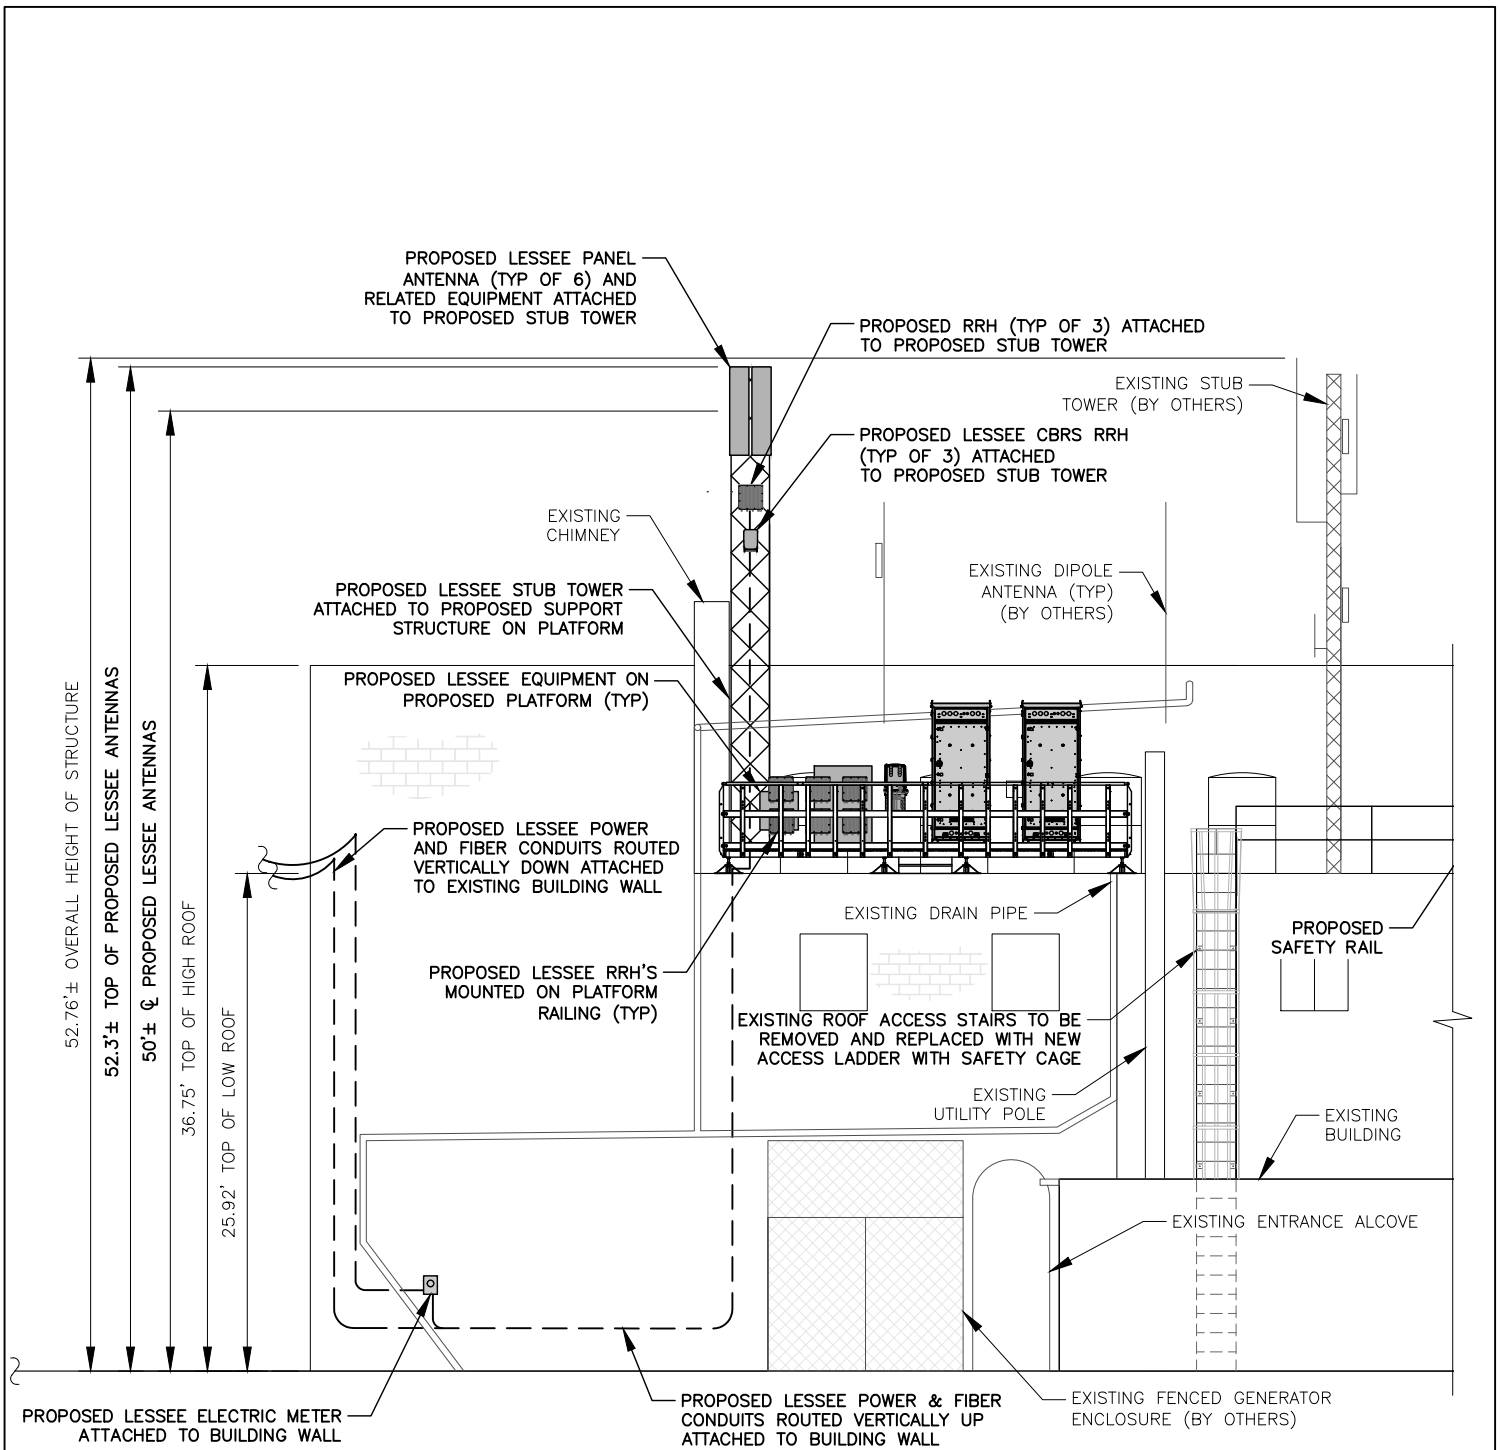

1 ELEVATION
LE-3 SCALE: 1" = 10'



Tectonic
PRACTICAL SOLUTIONS. EXCEPTIONAL SERVICE.

Tectonic Engineering Consultants, Geologists & Land Surveyors, D.P.C.
Project Contact Info
36 British American Blvd. Phone: (518) 783-1630
Suite 101 (800) 829-6531
Latham, NY 12110 www.tectonicengineering.com

SCHNEIDER AVE – LEASE EXHIBIT

PROJECT # 20202142274 – LOCATION CODE # 636584

303 MAIN ST – VILLAGE OF HIGHLAND FALLS – ORANGE COUNTY, NY 10928

VERIZON WIRELESS OF THE EAST, LP
(LESSEE)

1275 JOHN STREET, SUITE 100, WEST HENRIETTA, NY 14586